


CABLE INDICATOR DETAIL

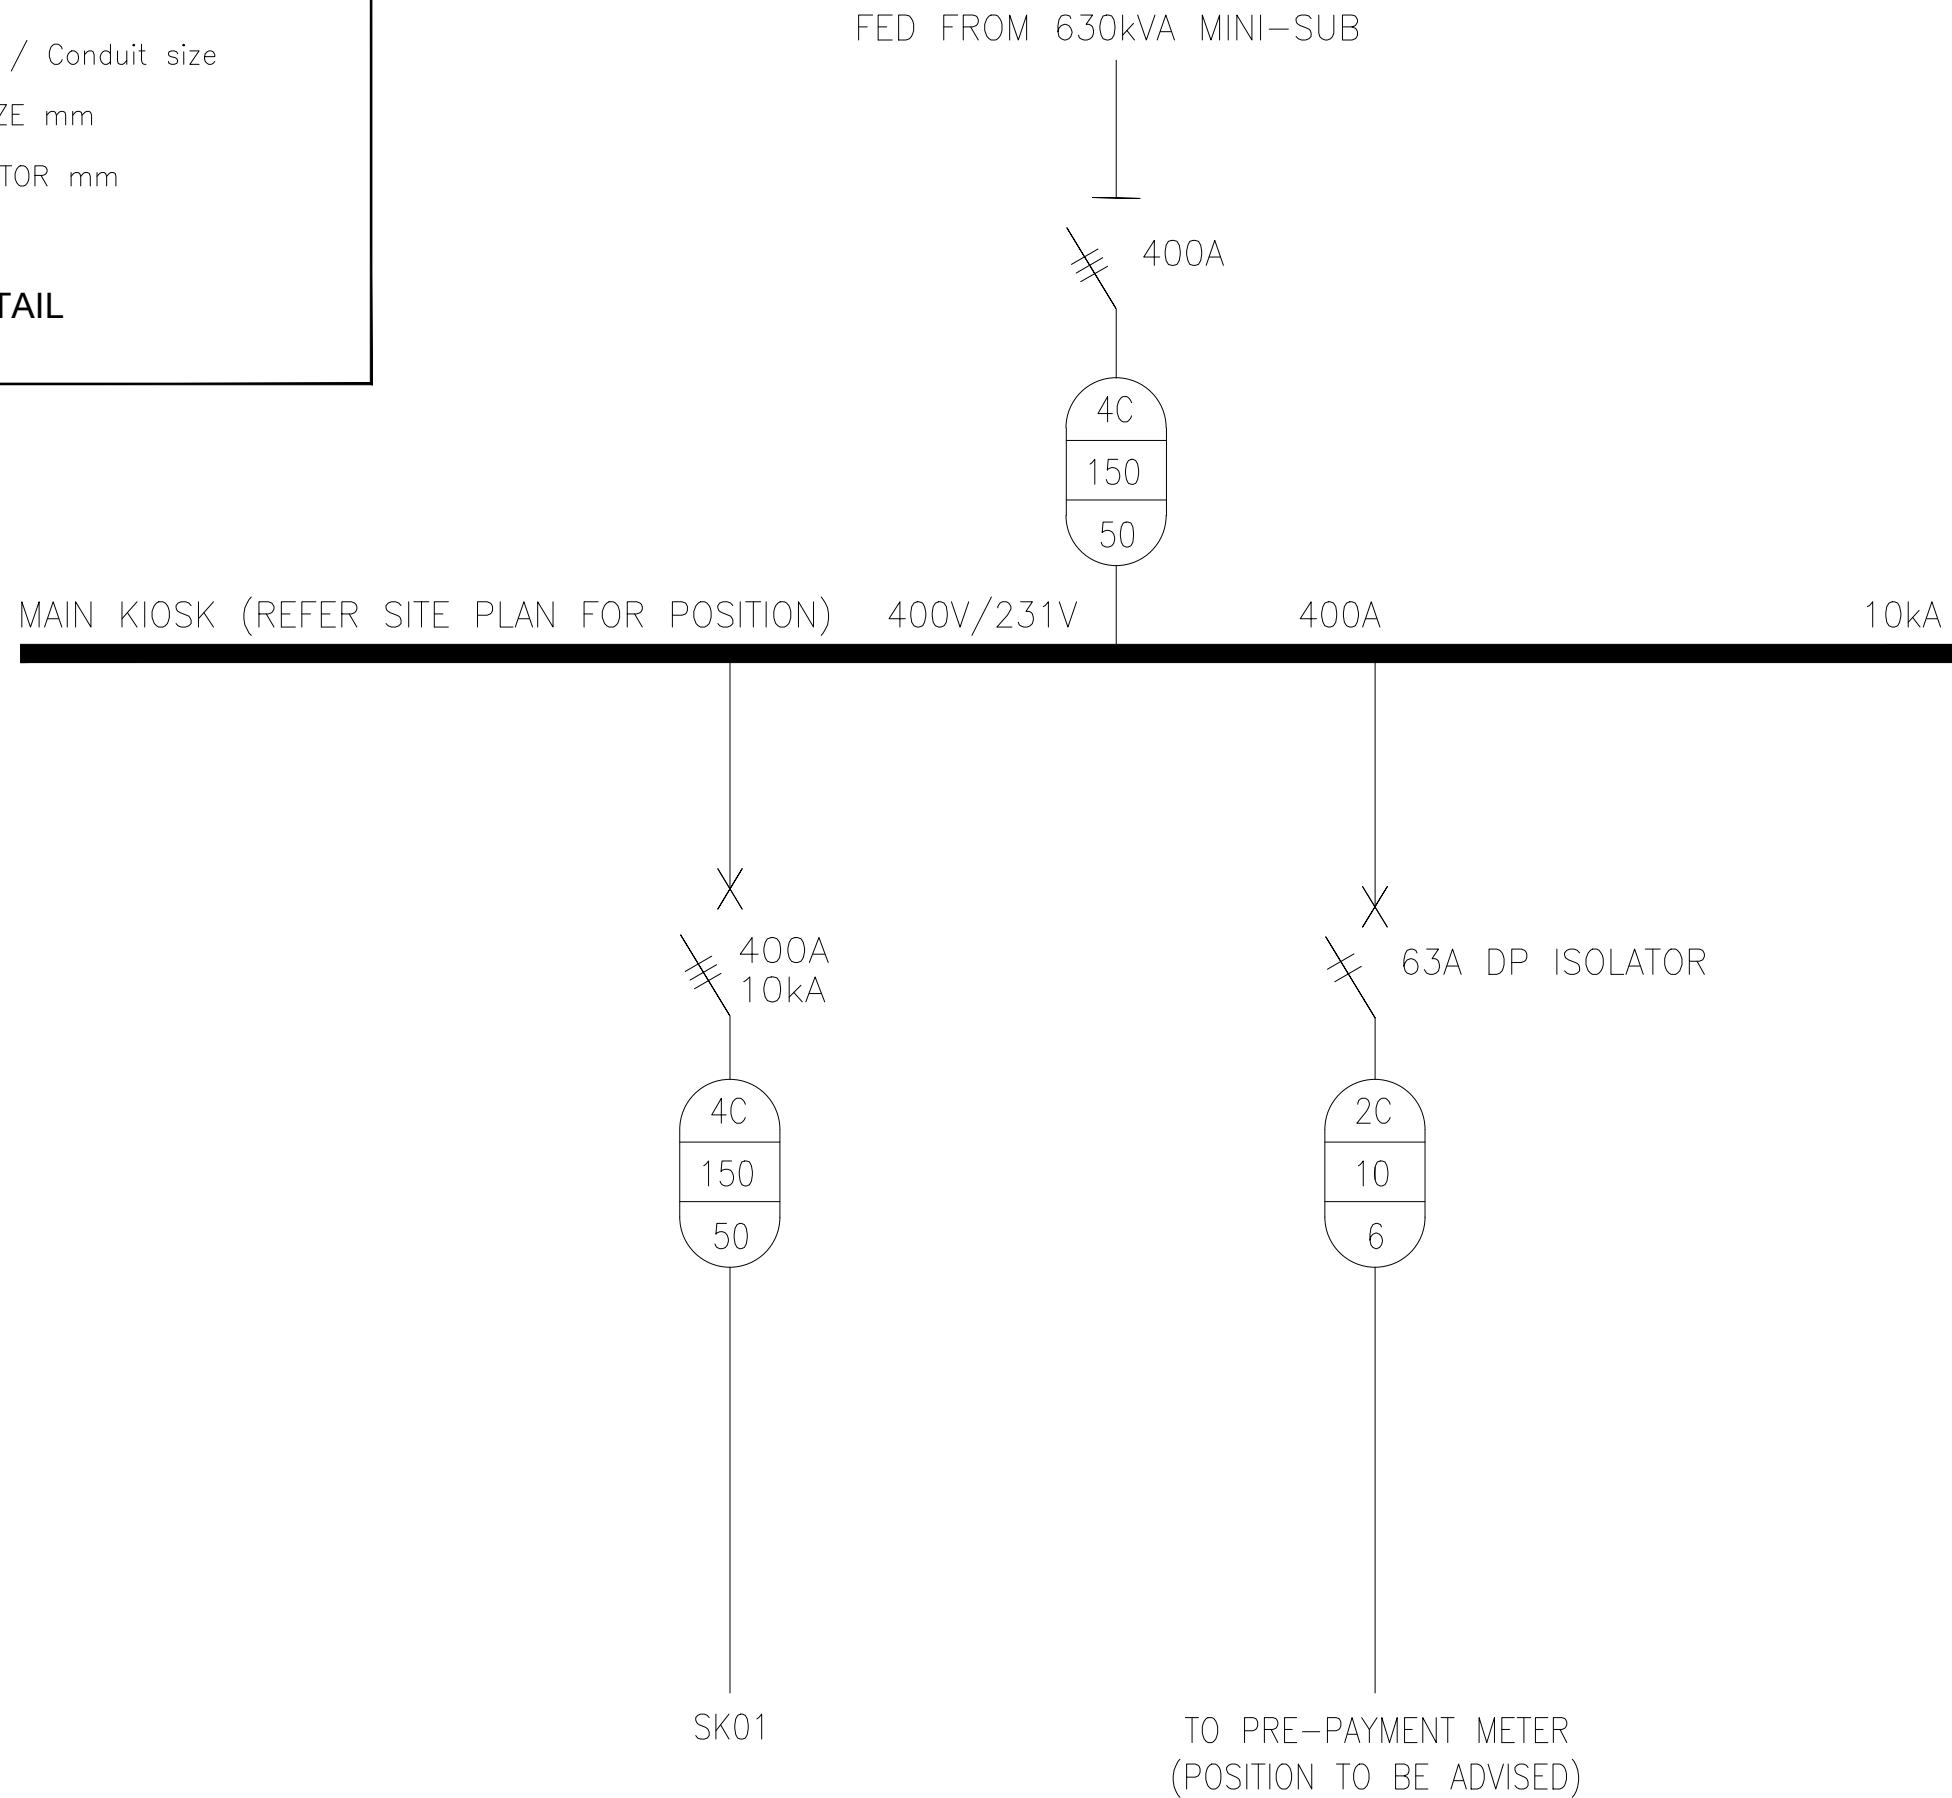

(A3 PLOT SIZE)



DRAWN BY MKDgroup
 DATE 02/06/22
 APPROVED K. Lloyd
 SCALE N.T.S

CLIENT
REDLINE GROUP

TITLE
**NAHOON VALLEY RIDGE DEVELOPMENT
 MAIN KIOSK SINGLE LINE DIAGRAM**

A	INFORMATION	02/06/2022
REV	DESCRIPTION	DATE
NVR/ELEC/101		REVISION
		A