


CABLE INDICATOR DETAIL

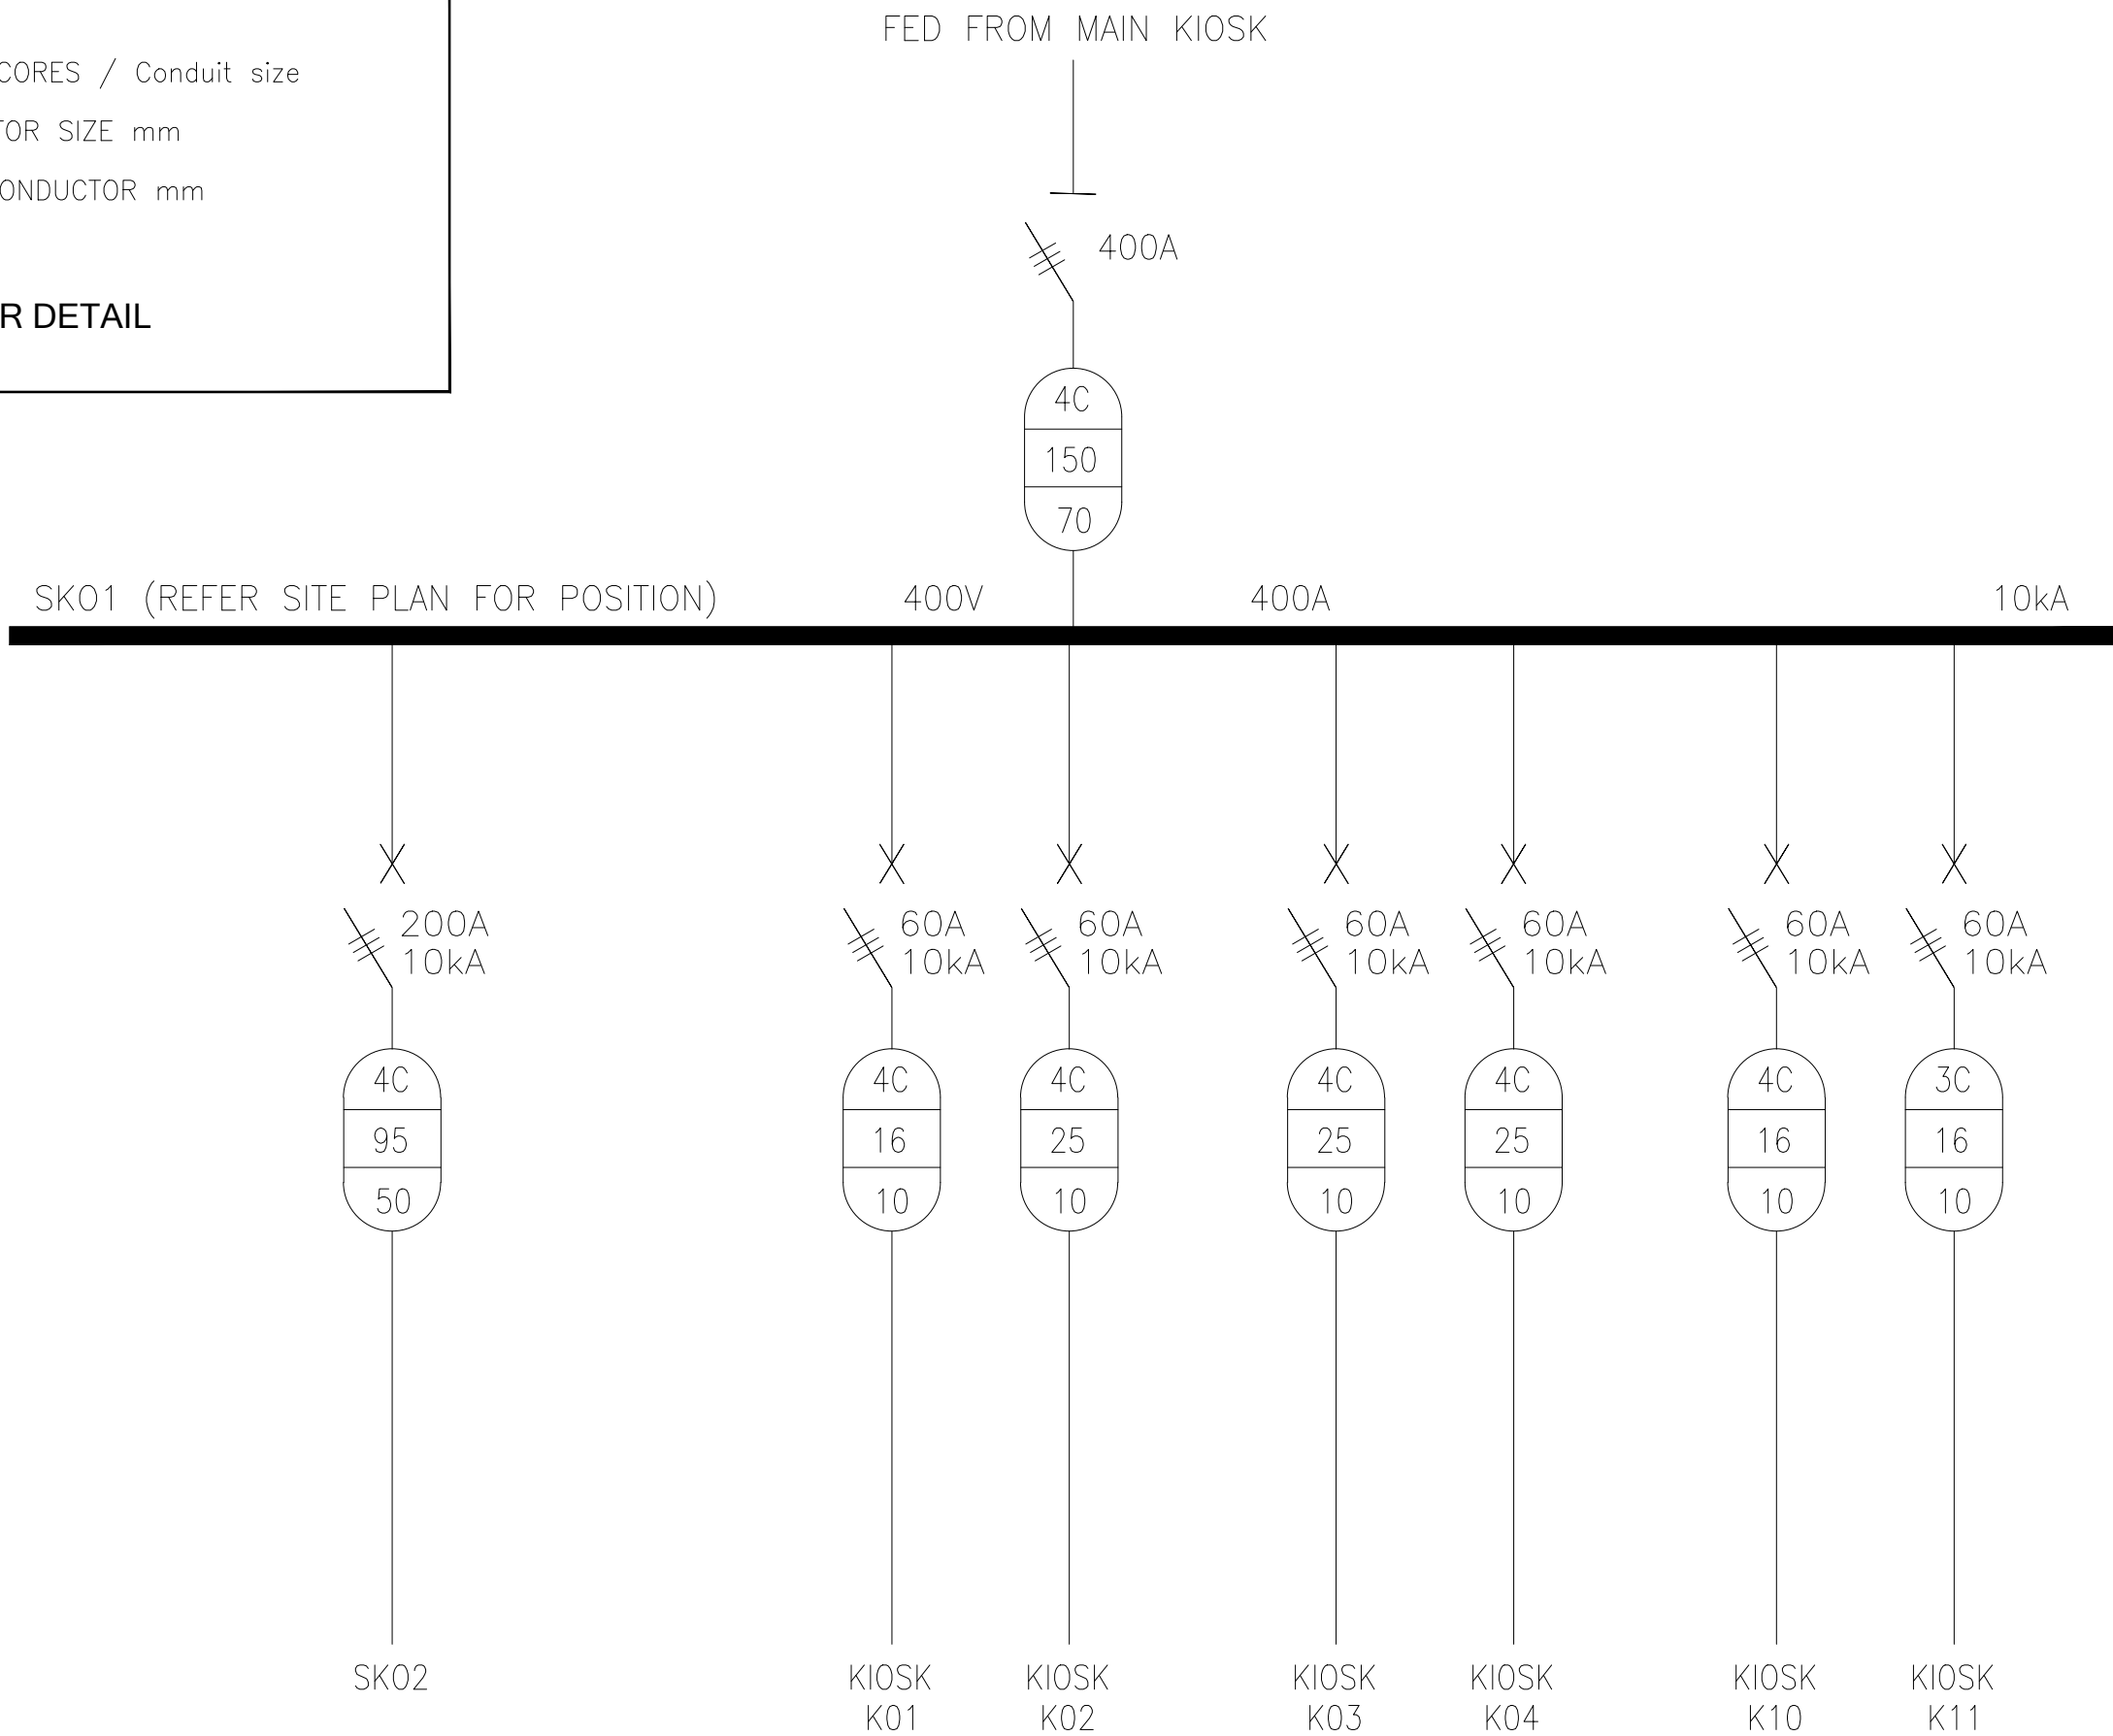

(A3 PLOT SIZE)



DRAWN BY	MKDgroup
DATE	02/06/22
APPROVED	K. Lloyd
SCALE	N.T.S

CLIENT
REDLINE GROUP

TITLE
**NAHOON VALLEY RIDGE DEVELOPMENT
SK01 KIOSK SINGLE LINE DIAGRAM**

A	INFORMATION	02/06/2022
REV	DESCRIPTION	DATE
NVR/ELEC/102		REVISION
		A