


CABLE INDICATOR DETAIL

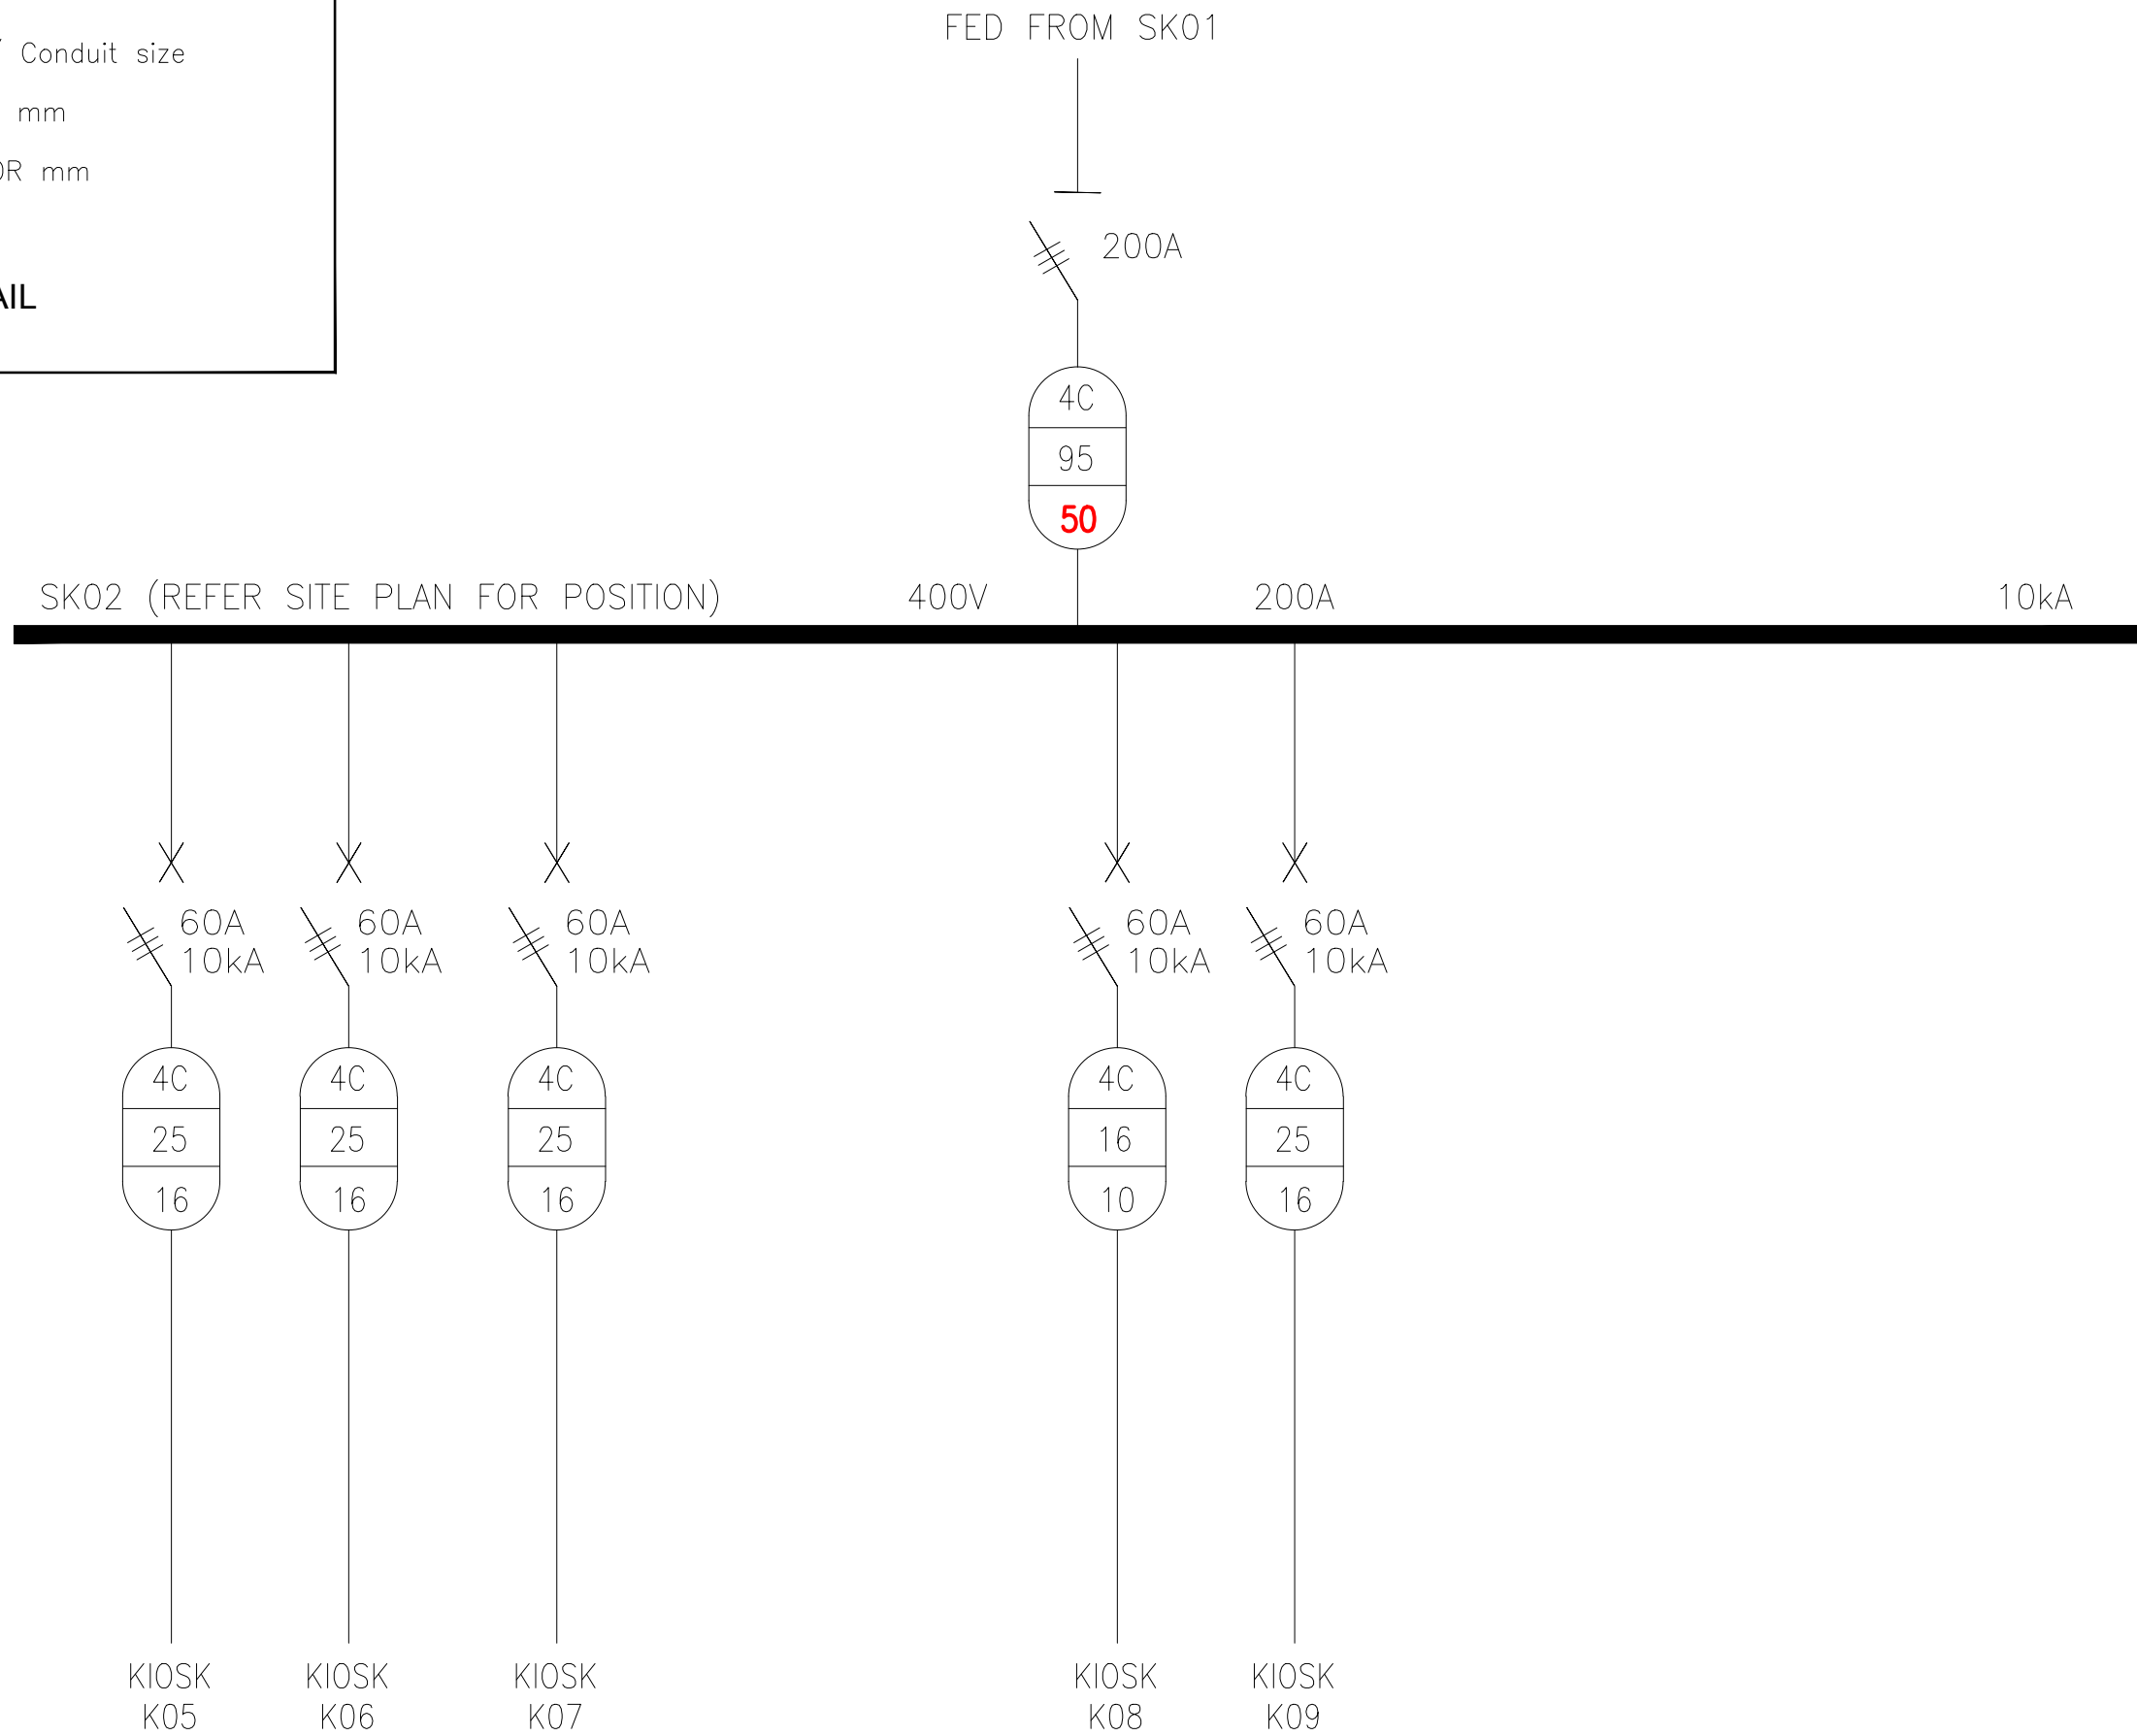

(A3 PLOT SIZE)



DRAWN BY	MKDgroup
DATE	02/06/22
APPROVED	K. Lloyd
SCALE	N.T.S

CLIENT  
**REDLINE GROUP**

TITLE  
**NAHOON VALLEY RIDGE DEVELOPMENT  
SK02 KIOSK SINGLE LINE DIAGRAM**

A	INFORMATION	02/06/2022
REV	DESCRIPTION	DATE
<b>NVR/ELEC/103</b>		<b>REVISION</b>
		<b>A</b>